

ORM WATER OFF AREA "C"

LEGEND:

- E.P. DENOTES EDGE OF PAVEMENT
- T.O.B. DENOTES TOP OF BANK
- S.M.H. DENOTES SEWER MANHOLE

4	UPDATE OUTFALL INFORMATION	5/22/95	AGP	WNT	AGP	AGP
3	REMOVE PROPANE & GAS CONT., ADD D. B. HOUSE OUTFALL	3/29/95	RFD	WNT	RFD	RFD
2	CHANGED OUTFALLS TO REFLECT SEWER ADDITION	1-26-94	RFD	GBS	RFD	RFD
1	ADDED RUNOFF AREA "E"	7-21-93	RFD	DCK	RFD	RFD
REV NO.	REVISION DESCRIPTION	DATE	DSN	DRN	CHKD	APPR



Public Service
of New Hampshire

General Engineering
Division

SIGNATURES	DATE	NPDES STORM WATER SITE PLAN SCHILLER STATION PORTMOUTH, N.H. <i>AK-191</i>
DSN: RFD	10/1/92	
DRN: GBS	10/1/92	
CHKD:		
APPR:		

SCALE: 1" = 40' DWG NO. R-6521-27

STORMWATER "A"

. 001
:NCY
. 015)

. 002
:NTACT
WATER)

LEGEND:

C.B. DENOTES CATCH BASIN


2	1995 REVISIONS	5/95	AGP	WNT	AGP	AGP
1	ADDED LINE CODE LEGEND	12/89		GBS		
REV NO.	REVISION DESCRIPTION	DATE	DSN	DRN	CHKD	APPR



**Public Service
of New Hampshire**

**General Engineering
Division**

SIGNATURES	DATE	SCHILLER STATION N.P.D.E.S. SITE PLAN <i>AR-190</i>				
DSN: AGP	9/7/89					
DRN: GBS	9/7/89					
CHKD: AGP	9/7/89					
APPR: AGP	9/7/89					
SCALE: 1" = 100'	DWG NO.	024601000_2				

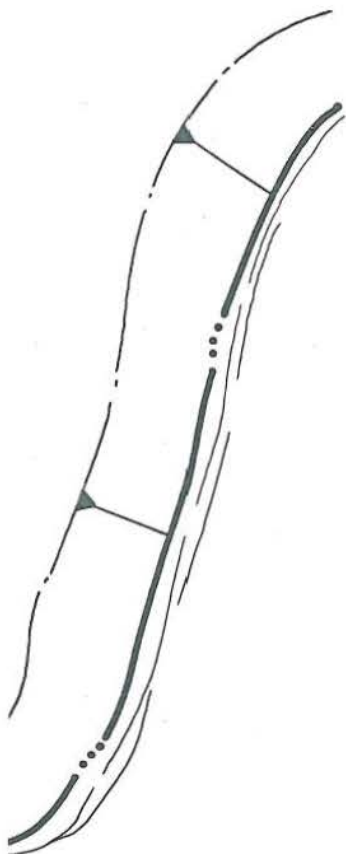

T7-40

AGP AGP IN CHKD APPR	DRAWN <i>W. TURNER</i>	PSNH Company of New Hampshire PUBLIC SERVICE ENGINEERING DIVISION	
	DESIGNED		
	CHECKED		
	APPROVED		
		SCHILLER STATION OVERVIEW OF WASTEWATER TREATMENT FACILITIES & DETAILS PORTSMOUTH, N. H.	
		SCALE <i>1" = 40'</i>	DATE <i>4/27/90</i>
		SHEET <i>1</i> OF <i>26</i>	DRAWING NO. <i>R-6521-26</i>

AR-189

CERTIFIED FOR CONSTRUCTION

REVISION 3 OF THIS DRAWING
SUPERSEDES AND CANCELS ALL
PREVIOUS ISSUES

BELCO

POLLUTION CONTROL CORP.

BY: A.S.
DATE 1-6-84

C.T. MAIN FOR
PUBLIC SERVICE CO. OF N.H.
SCHILLER STATION UNITS 4, 5, & 6
COAL CONVERSION PROJECT
P.O. No 187007
BELCO JOB No 56045

THIS DRAWING IS THE PROPERTY OF THE
BELCO POLLUTION CONTROL CORPORATION
119 LITTLETON ROAD, PARSIPPANY, N.J. 07054



AND IS LOANED UPON CONDITION THAT IT IS NOT TO BE
REPRODUCED OR COPIED, IN WHOLE OR IN PART, OR USED FOR
FURNISHING INFORMATION TO ANY PERSON OR COMPANY
WITHOUT THE PRIOR WRITTEN CONSENT OF THE CORPORATION,
OR FOR ANY PURPOSE DETRIMENTAL TO THE CORPORATION'S
INTEREST, AND SHALL BE RETURNED UPON REQUEST.

TITLE

P & I D
WASTEWATER SYSTEM

DRN VIVENTI	DATE 3-1-83	SCALE <u>2</u>	JOB NO 56045
CHK.	DATE	DWG. NO.	REV
APP.	DATE	56045-20-E-2	3

ZONE	DRN	CHK	DATE	NO	REVISION	ZONE	DRN	CHK	DATE
				3	REV. AS NOTED		WJL		1-6-84
				2	ADDED NOTE #6 & AS NOTED		KE		7-19-83
				1	GENERAL REVISION		B9		6-1-83
				0	INITIAL ISSUE		VV		3-1-83

2

3299 1-03-0001
AR-188

E

A

AR-188